


- KEY NOTES:**
- ① 44'-0" CONTINUOUS SIDE WALL SLOT DIFFUSER. UNUSED SECTIONS HAVE NO ATTACHED DUCT PLENUM. PROVIDE BLANK-OFF IN UNUSED SECTION.
  - ② WIRELESS TEMPERATURE SENSOR.
  - ③ INSTALL BRANCH DUCT TO EXHAUST GRILLE WITH AT LEAST TWO ELBOWS.
  - ④ PROVIDE SECONDARY DRAIN PAN UNDER HEATING COIL OVER CABLE TRAY.
  - ⑤ MOUNT AT 8'-7" ABOVE FINISHED FLOOR IN THE LIGHT COVE.
  - ⑥ TU-213
  - ⑦ TU-212
  - ⑧ TU-211
  - ⑨ TU-287
  - ⑩ TU-208
  - ⑪ TU-207
  - ⑫ EG2-210.
  - ⑬ CD2-135.
  - ⑭ EG1-150.
  - ⑮ DDC CONTROL PANEL.
  - ⑯ EG5-80.

**2ND FLOOR PLAN - SOUTH - HVAC**  
 SCALE: 1/8"=1'-0"

**GIFFIN • BOLTE • JURGENS**  
 ARCHITECTS  
 815 S.W. SECOND AVENUE • PORTLAND, OREGON 97204  
 (503) 223-0992 www.gbjaarch.com FAX (503) 294-3961

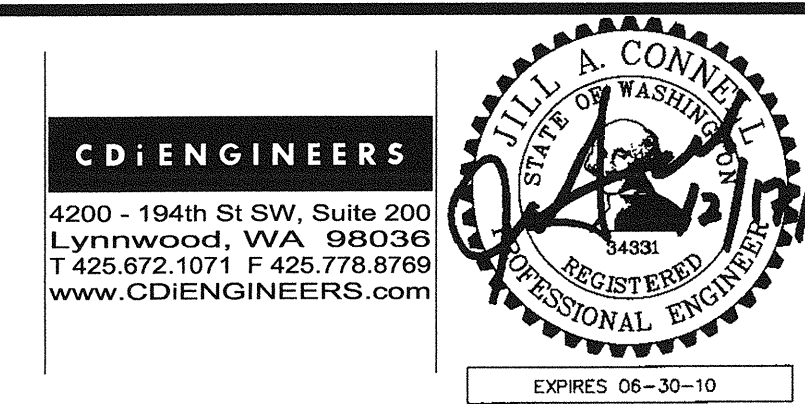

**MultiCare**  
**EMERGENCY DEPARTMENT & CANCER CENTER EXPANSION**  
 TACOMA, WASHINGTON

△ CCD 04	12-17-08

Date 09-26-2008  
 Scale 1/8"=1'-0"  
 Drawn By CDi  
 Job No. 4034

**2ND FLOOR PLAN - SOUTH - HVAC**

**M4  
02**