








CONSTRUCTION NOTES



-  CONSTRUCT
  REMODEL EXISTING
-  EXISTING
  REMOVE AND CONSTRUCT
-  REMOVE
  WORK BY OTHERS

NOTES:


1. FOR CONSTRUCTION NOTES SEE DWG CGG-101.
2. SEE UTILITY PLANS (UR) FOR EXISTING UTILITIES. UR-3C-302
3. SEE STREET IMPROVEMENT PLANS (CA) FOR PROPOSED CONSTRUCTION OF ROADWAY IMPROVEMENTS AND VERIFICATION OF RIM ELEVATIONS.
4. SEE STREET LIGHTING PLANS (SL) FOR EXACT LOCATIONS AND DETAILS.
5. SEE TRAFFIC SIGNAL PLANS (TR) FOR TRAFFIC SIGNAL POLE AND EQUIPMENT LOCATIONS AND DETAILS.
6. SEE SIGNING AND STRIPING PLANS (SS) FOR SIGNING AND STRIPING LOCATIONS AND DETAILS.
7. SEE TRACKWORK PLANS (T) FOR TRACK RELATED WORK.
8. SEE RIGHT-OF-WAY PLANS FOR RIGHT-OF-WAY TAKE AND TEMPORARY CONSTRUCTION EASEMENTS.
9. SEE DUCTBANK PLANS (NX) FOR EXACT LOCATIONS AND DETAILS.
10. SEE GUIDEWAY PLANS (GC) FOR FENCE REQUIREMENTS IN METRO R/W.
11. SEE GRADE CROSSING PLANS (GX) FOR GRADE CROSSING EQUIPMENT LOCATIONS AND DETAILS.
12. SEE FIBER OPTIC PLANS (NA) FOR EXACT LOCATION OF CSM FIBER OPTIC INTERCONNECT.
13. CONTRACTOR TO VERIFY EXISTING UTILITY LOCATIONS AND DEPTH.
14. ALL NEW AND REMOVED/REPLACED CATCH BASINS UNDER THIS PROJECT SHALL INCLUDE CATCH BASIN FILTER INSERTS AND CATCH BASIN OPENING SCREENS. REUSE EXISTING INSERTS AND SCREENS WHEN APPLICABLE.
15. ALL NEW AND REMOVED/REPLACED CATCH BASINS UNDER THIS PROJECT SHALL BE STENCILED WITH PROHIBITIVE LANGUAGE, "NO DUMPING - DRAINS TO OCEAN".
16. OBTAIN LACFCD PERMIT PRIOR TO TIE IN TO ALL LACFCD FACILITIES.
17. SEE TRACTION POWER SYSTEMS PLANS (P) FOR GRADING DETAILS FOR TPSS & RADIO SITES.
18. STATIONING OFF R TRACK UNLESS OTHERWISE NOTED.

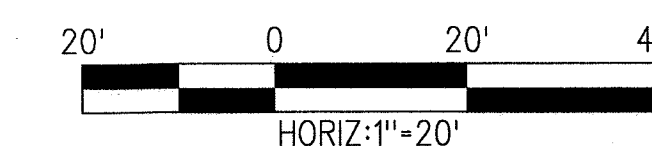

SRJV
FEB 27 2014
ISSUED FOR
CONSTRUCTION



	12/9/13	NM	RCW	C78128	9/30/15	ROBERT C. WELCH	ECI 41
	3/8/13	NM	RCW	C78128	9/30/13	ROBERT C. WELCH	ECI 03
0	12/14/12	NM	RCW	C78128	9/30/13	ROBERT C. WELCH	APPROVED FOR CONSTRUCTION
REV	DATE	BY	APP	REG NO	EXPIRES	SEAL HOLDER	DESCRIPTION

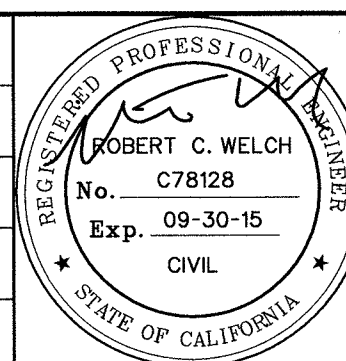DESIGNED BY
N. MELTON
DRAWN BY
N. MELTON
CHECKED BY
J. SCHICK
IN CHARGE
R. WELCH
DATE
3/8/13



	<p>Exposition Metro Line Construction Authority</p>	<p>EMCA</p>
	<p>444 South Flower Street Suite 2200 Los Angeles, CA 90071 TEL (213) 443-7463 FAX (213) 362-9481</p>	<p>PARSONS BRINCKERHOFF</p>

EXPOSITION LRT PROJECT- PHASE 2
STORM DRAIN SEGMENT 3C
COLORADO AVE / 5TH ST
PLAN
STA 13+50 TO STA 15+40

CONTRACT NO XP8902-002	
DRAWING NO CD-3C-302	
SCALE HOR: 1"=20' VERT: 1"=4'	
SHEET NO 45 OF 108	

HernandezH	3:10:32 PM	12/9/2013	C:\Users\hernandezh\Desktop\WELCH9-2\expo2-cd-3C-302.plt
Plot Driver=EXP02-Full-BW-pdf.plt		Pentable=EXP02-PENTABLE.tbl	

SCALES	HORIZ SCALE: 1"=20'	SHEET	INDEX NUMBER
	VERT SCALE: 1"=4'		